

DOOR SCHEDULE

ALL DOORS IN HOLLOW METAL FRAMES, PAINTED

- ① 3X7 SCW, PASSAGE, WIRE FOR ELEC STRIKE BY TENANT
- ②
- ③
- ④
- ⑤
- ⑥
- ⑦
- ⑧
- ⑨ 3X7 SCW, PUSH/PULL, CLOSER


BORROW LIGHTS

CLEAR TEMPERED GLASS IN HOLLOW METAL FRAMES, PAINTED

- (A) 3) 6'x2' @ 6'-6" AFF
- (B) 3) 4'x4' @ 3'-6" AFF
- (C) 1) COUNTER W/2" PASS-THRU SLOT @ 3'-6" AFF
- (D) 1) 6'x4' @ 3'-6" AFF

ELECTRICAL SYMBOL KEY:


- ⌘ SWITCH AT 36" AFF
- ▷ PHONE/DATA STUB ABOVE CEILING
- WALL MTD @ 54" VOICE ONLY
- ⊕ RECEPTACLE AT 19" AFF
- GF1 GROUND FAULT @ 42" AFF
- ⊗ EMERGENCY BATTERY PACK
- ⊗ EXIT LIGHT
- ⊕ HEAT ALARM (120V - INTERCONNECTED)
- ⊕ CARBON MONOXIDE (120V - INTERCONNECTED)
- INCANDESCENT FIXTURE
- ▨ 2X4 FLUOR TROFFER LAMP: 4-T8 CW 120V LENS: ACRYLIC
- ▭ 2X4 FLUOR TROFFER LAMP: 2-T8 CW 120V LENS: ACRYLIC
- NL NIGHT LIGHT
- E EXHAUST FAN ON LIGHT SWITCH

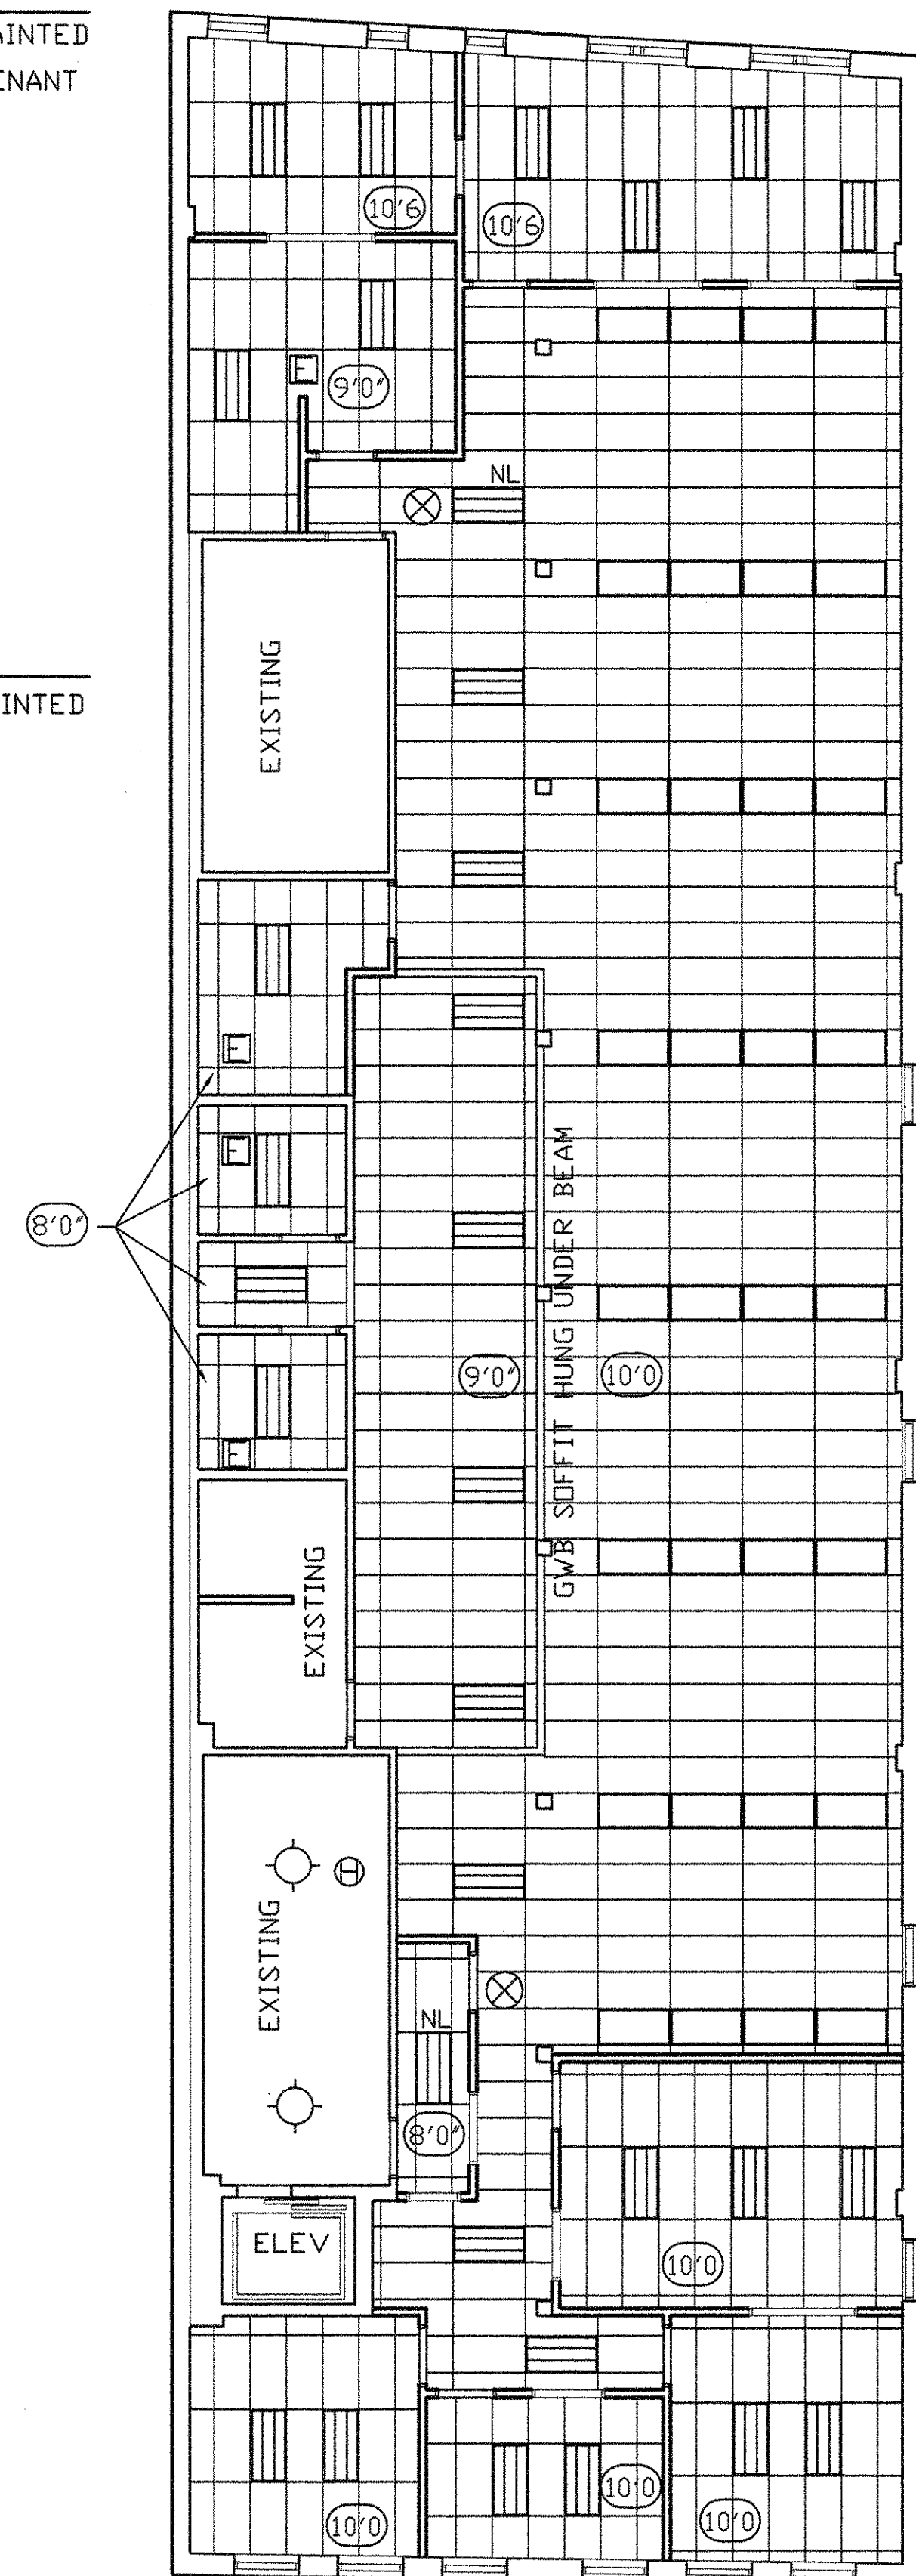

CEILING PLAN


ALL CEILING HEIGHTS SHALL BE COORDINATED WITH SPACE REQUIREMENTS OF DUCT RUNS

PIPE UP FROM FLOOR AT BRICK EXTERIOR WALL

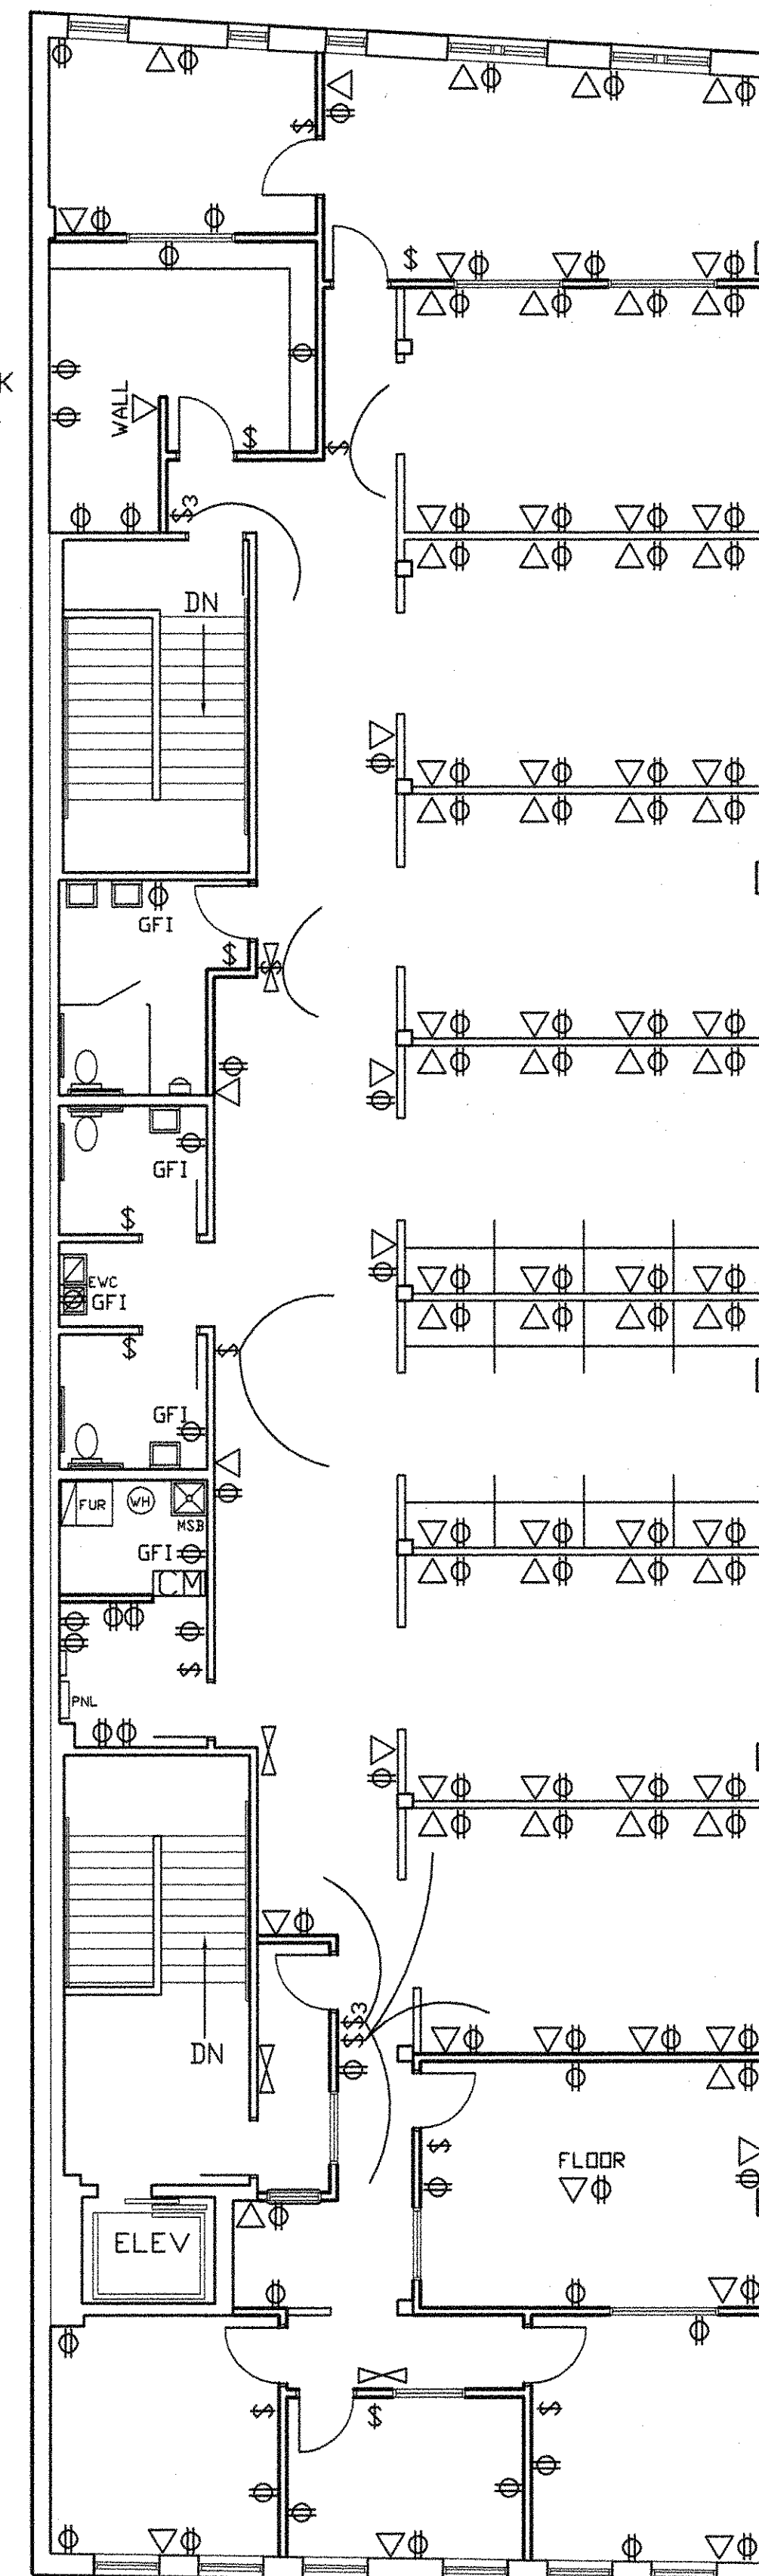


POWER PLAN

PIPE UP FROM FLOOR AT BRICK EXTERIOR WALL

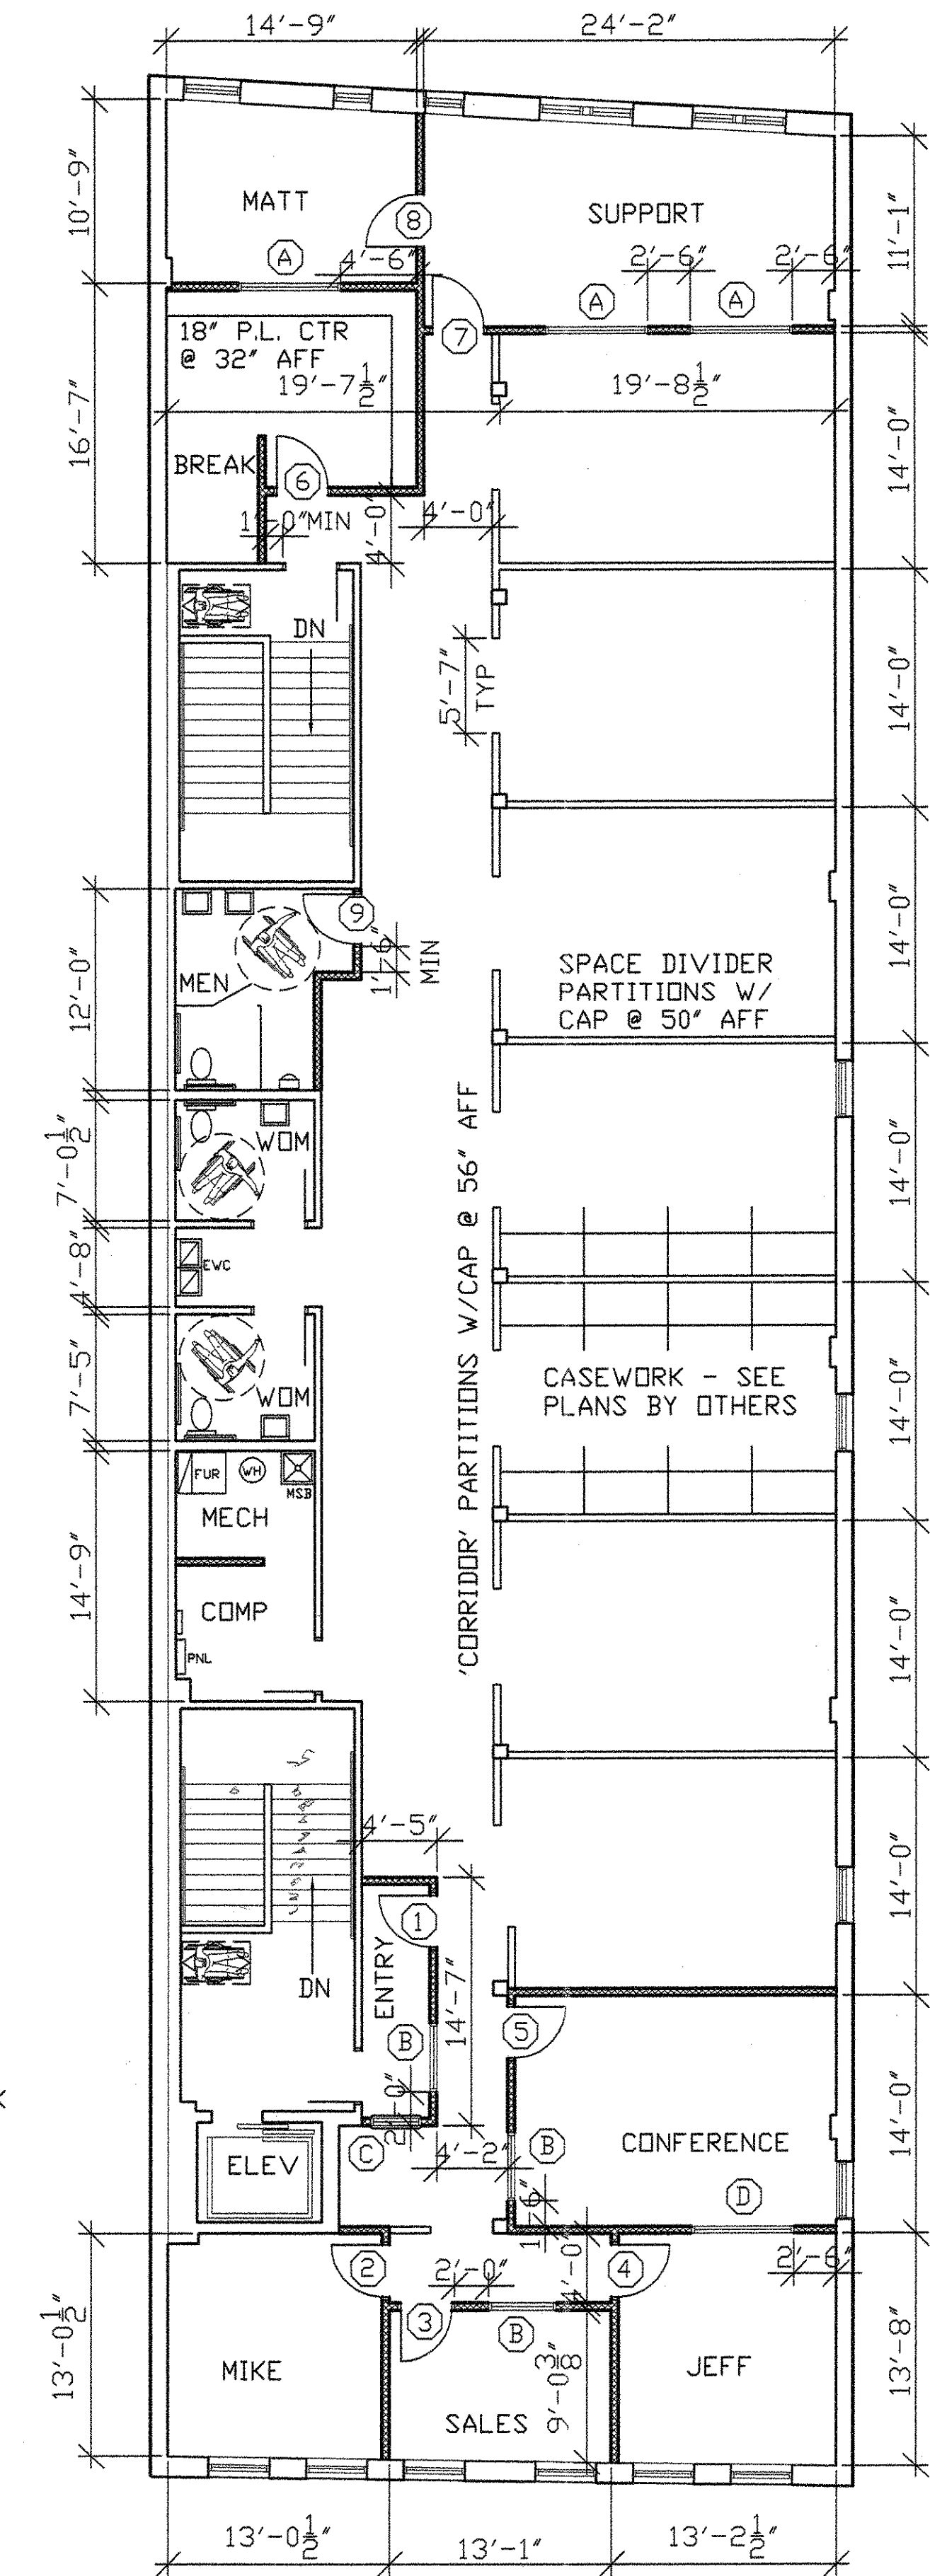


FLOOR PLAN


SCALE: 1/8" = 1'-0" NORTH

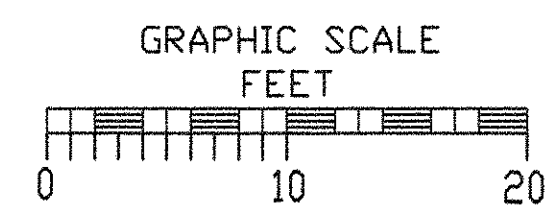

PARTITION WALLS ARE ASSUMED 5" THICK
PLUMBING WALLS ARE ASSUMED 7" THICK
ALL DIMENSIONS ARE APPROXIMATE - FIT TO EXISTING CONDITIONS

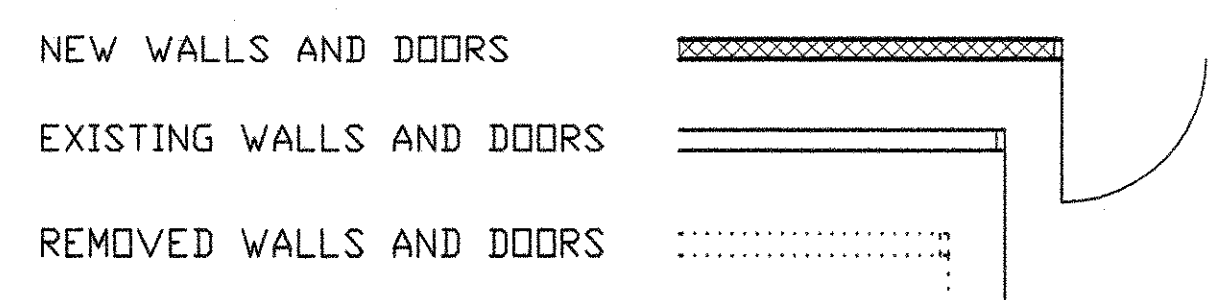

LARRY R. PAUSTIAN
ARCHITECTS, P.C.
144 DAKMOOR DRIVE EAST PEORIA, IL 61611
309-694-3947

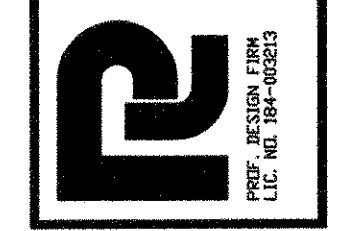

JOB NO. 2358

EAGLE RECOVERY
IRON FRONT BUILDING - THIRD FLOOR
424 S.W. WASHINGTON STREET
HUBER BROTHERS CORPORATION 611 S.W. WASHINGTON PEORIA, IL

PRELIMINARY UNTIL SIGNED APPROVED FOR CONSTRUCTION	
X	OWNER'S REP.
X	CONTRACTOR
X	ARCHITECT

REVISIONS:	
△ / /	
△ / /	
△ / /	
△ / /	

DATE: 12/3/03

SHEET:
2
3

THIS DRAWING, THE CONCEPT, IDEAS, AND INFORMATION CONTAINED HEREIN ARE THE PROPERTY OF THE ARCHITECT AND ARE NOT TO BE COPIED, DUPLICATED, OR USED IN ANY FASHION, FOR DISCUSSION, OR CONSTRUCTION WITHOUT WRITTEN PERMISSION.